


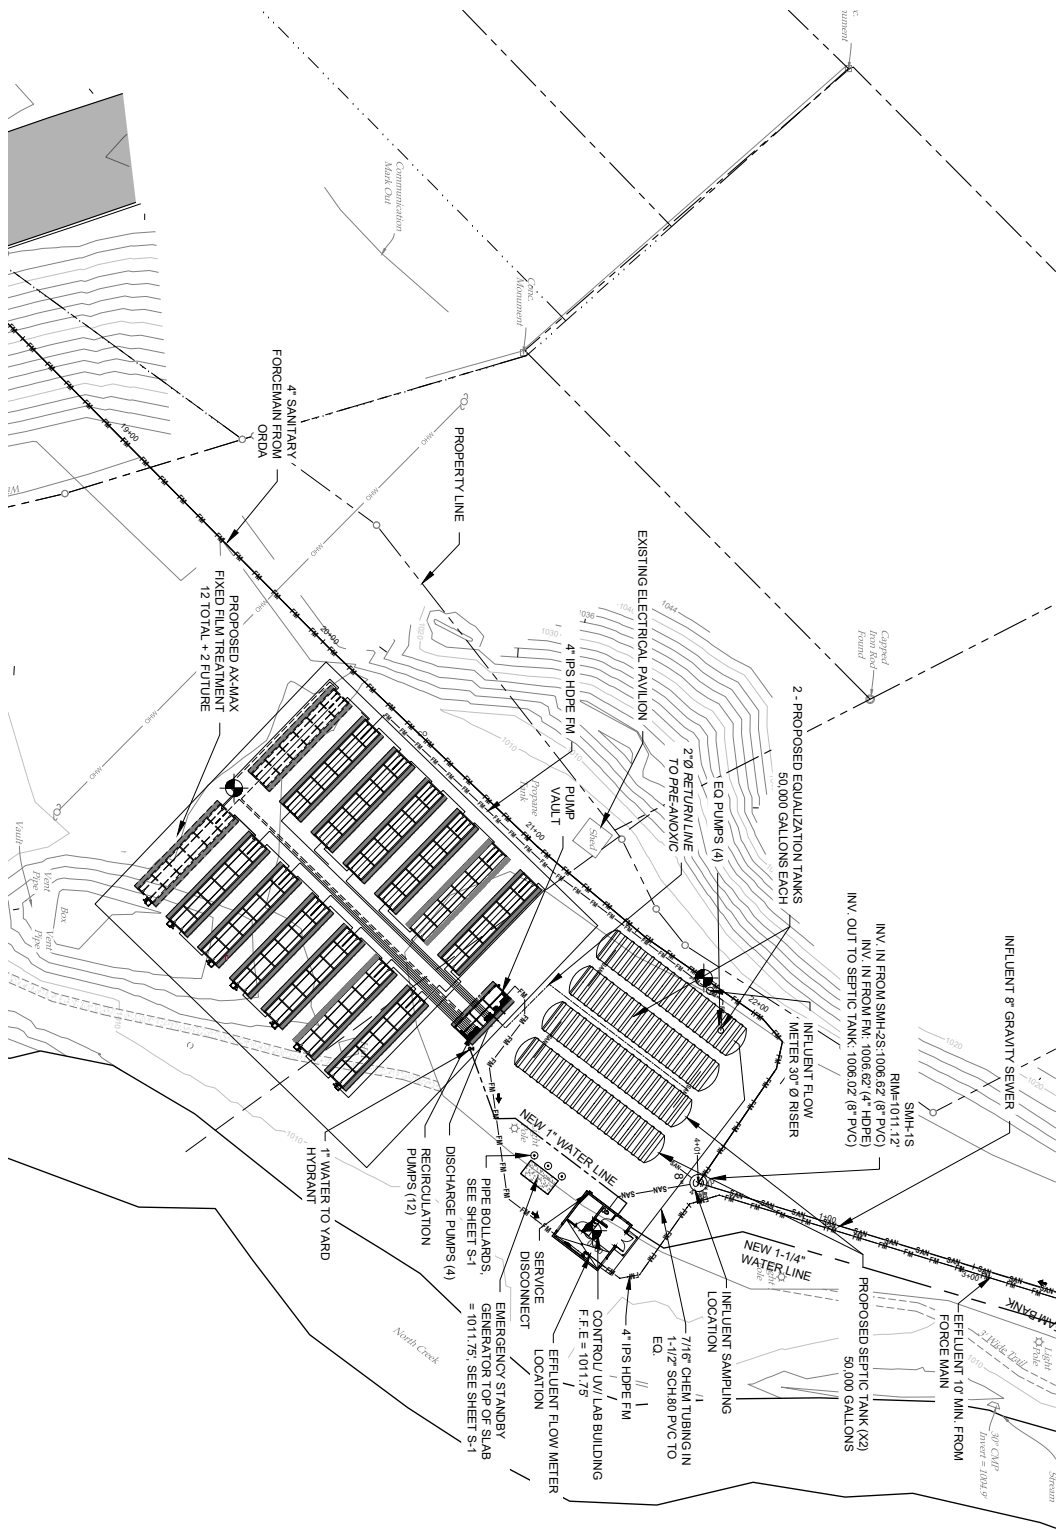

1
PROPOSED WASTEWATER TREATMENT - PRELIMINARY SITE PLAN
SCALE: 1"= 20'

NYSDEC PERMITTING PLANS

20-01 DESIGNED BY: JAC DRAWN BY: JAC REVIEWED BY: BTB PROJECT NUMBER:	PROJECT NAME: PROPOSED WASTEWATER SYSTEM	CLIENT NAME: HAMLET OF NORTH CREEK JOHNSBURG TOWN HALL 219 MAIN STREET NORTH CREEK, NY 12853	1. THIS DOCUMENT IS THE PROPERTY OF THE ENGINEER. IT IS TO BE USED ONLY FOR THE PROJECT AND SITE SPECIFICALLY IDENTIFIED HEREON. IT IS NOT TO BE REPRODUCED, COPIED, EITHER WHOLLY OR IN PART, OR TRANSMITTED IN ANY FORM OR BY ANY MEANS, WITHOUT THE WRITTEN PERMISSION OF THE ENGINEER.		REVISIONS:	
	SHEET NAME: PROPOSED WWTP SITE PLAN	NO. DATE: DESCRIPTION:				
					1 1/18/2024 NYDEC COMMENTS	

